



## LEGEND

--- AMBIT OF LICENSED PREMISES

LIQUOR STORAGE

LIQUOR SALES

WC, PASSAGEWAY, ETC

SAFETY LIGHTING

HEAT DETECTOR

SMOKE DETECTOR

CARBON DIOXIDE FIRE EXTINGUISHER

9lt. WATER FIRE EXTINGUISHER

FOAM FIRE EXTINGUISHER

FIRE BLANKET

WET CHEMICAL FIRE EXTINGUISHER

INTERNALLY ILLUMINATED FIRE ESCAPE SIGN (BS 5266)

**FD30S** 30min FIRE RESISTANCE DOOR (fire door to have intumescent strips and self closer)


CALL POINT FIRE ALARM (BS 5839)

FIRE SOUNDER

ALARM PANEL

CCTV OPERATING SYSTEM

TOTAL AREA: 72.02 m<sup>2</sup>

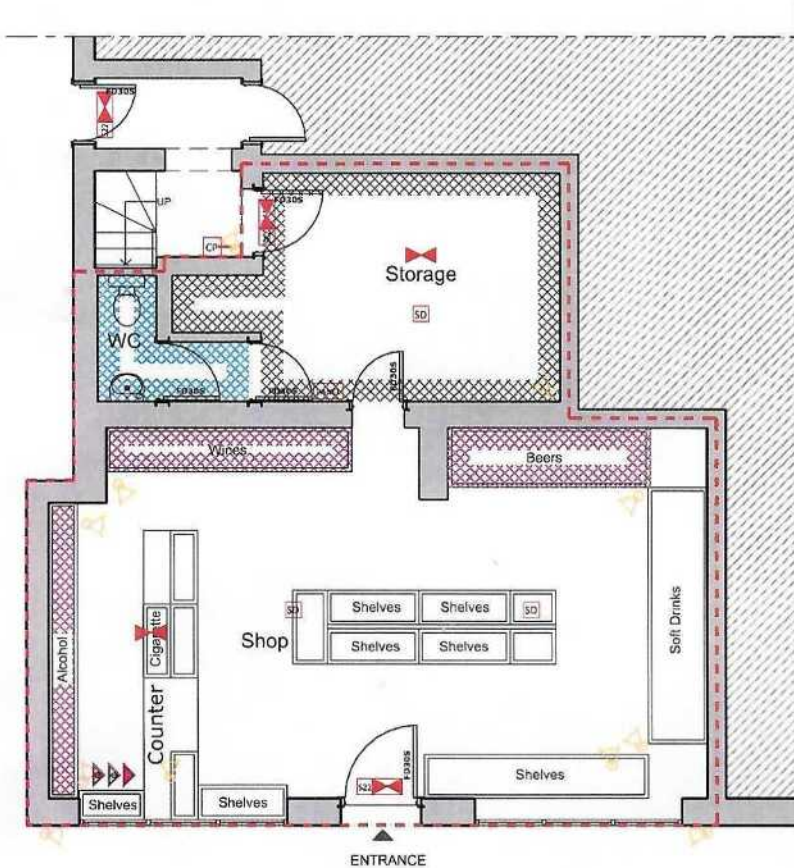


## GROUND FLOOR PLAN

Scale 1:100

### Notes

 - 1- This drawing is not for construction
- 2- All Dimensions are in millimeters
- 3- Dimensions are not to be scaled directly from drawings
- 4- All dimensions are to be checked on site and the Architect is to be informed of any discrepancies before construction commences
- 5- All references to drawings refer to current revision of that drawing
- 6- The Copyright of this drawing belongs to Architectural Design Point Limited.



Rev.	Date	Revisions
<b>FOR LICENSING</b>		
 <b>ARCHITECTURAL DESIGN POINT</b> 8-10 Silver Street, Enfield, EN1 3ED Office: 0208 367 7479 Tel: 0796 029 9656 Email: info@adplondon.co.uk		
Client		Mr Arumugam Sarakan
Project 112 Bridge Road, Sutton Bridge, PE12 9SA		
Scale	1/100@A4	Date 11/2021
Drawn By	I.C	Checked By H.C
Project No.	Drawing No.	Revision
211103-01	A101	-
Drawing title		
Ground Floor Plan		